


GROUND FLOOR PLAN


SCALE 1/4"=1'-0"

NOTE-
FLOOD VENTS INSTALLED AS REQUIRED
NO ELECTRICAL, PLUMBING, OR MECHANICAL
EQUIPMENT BELOW BASE FLOOD ELEVATION

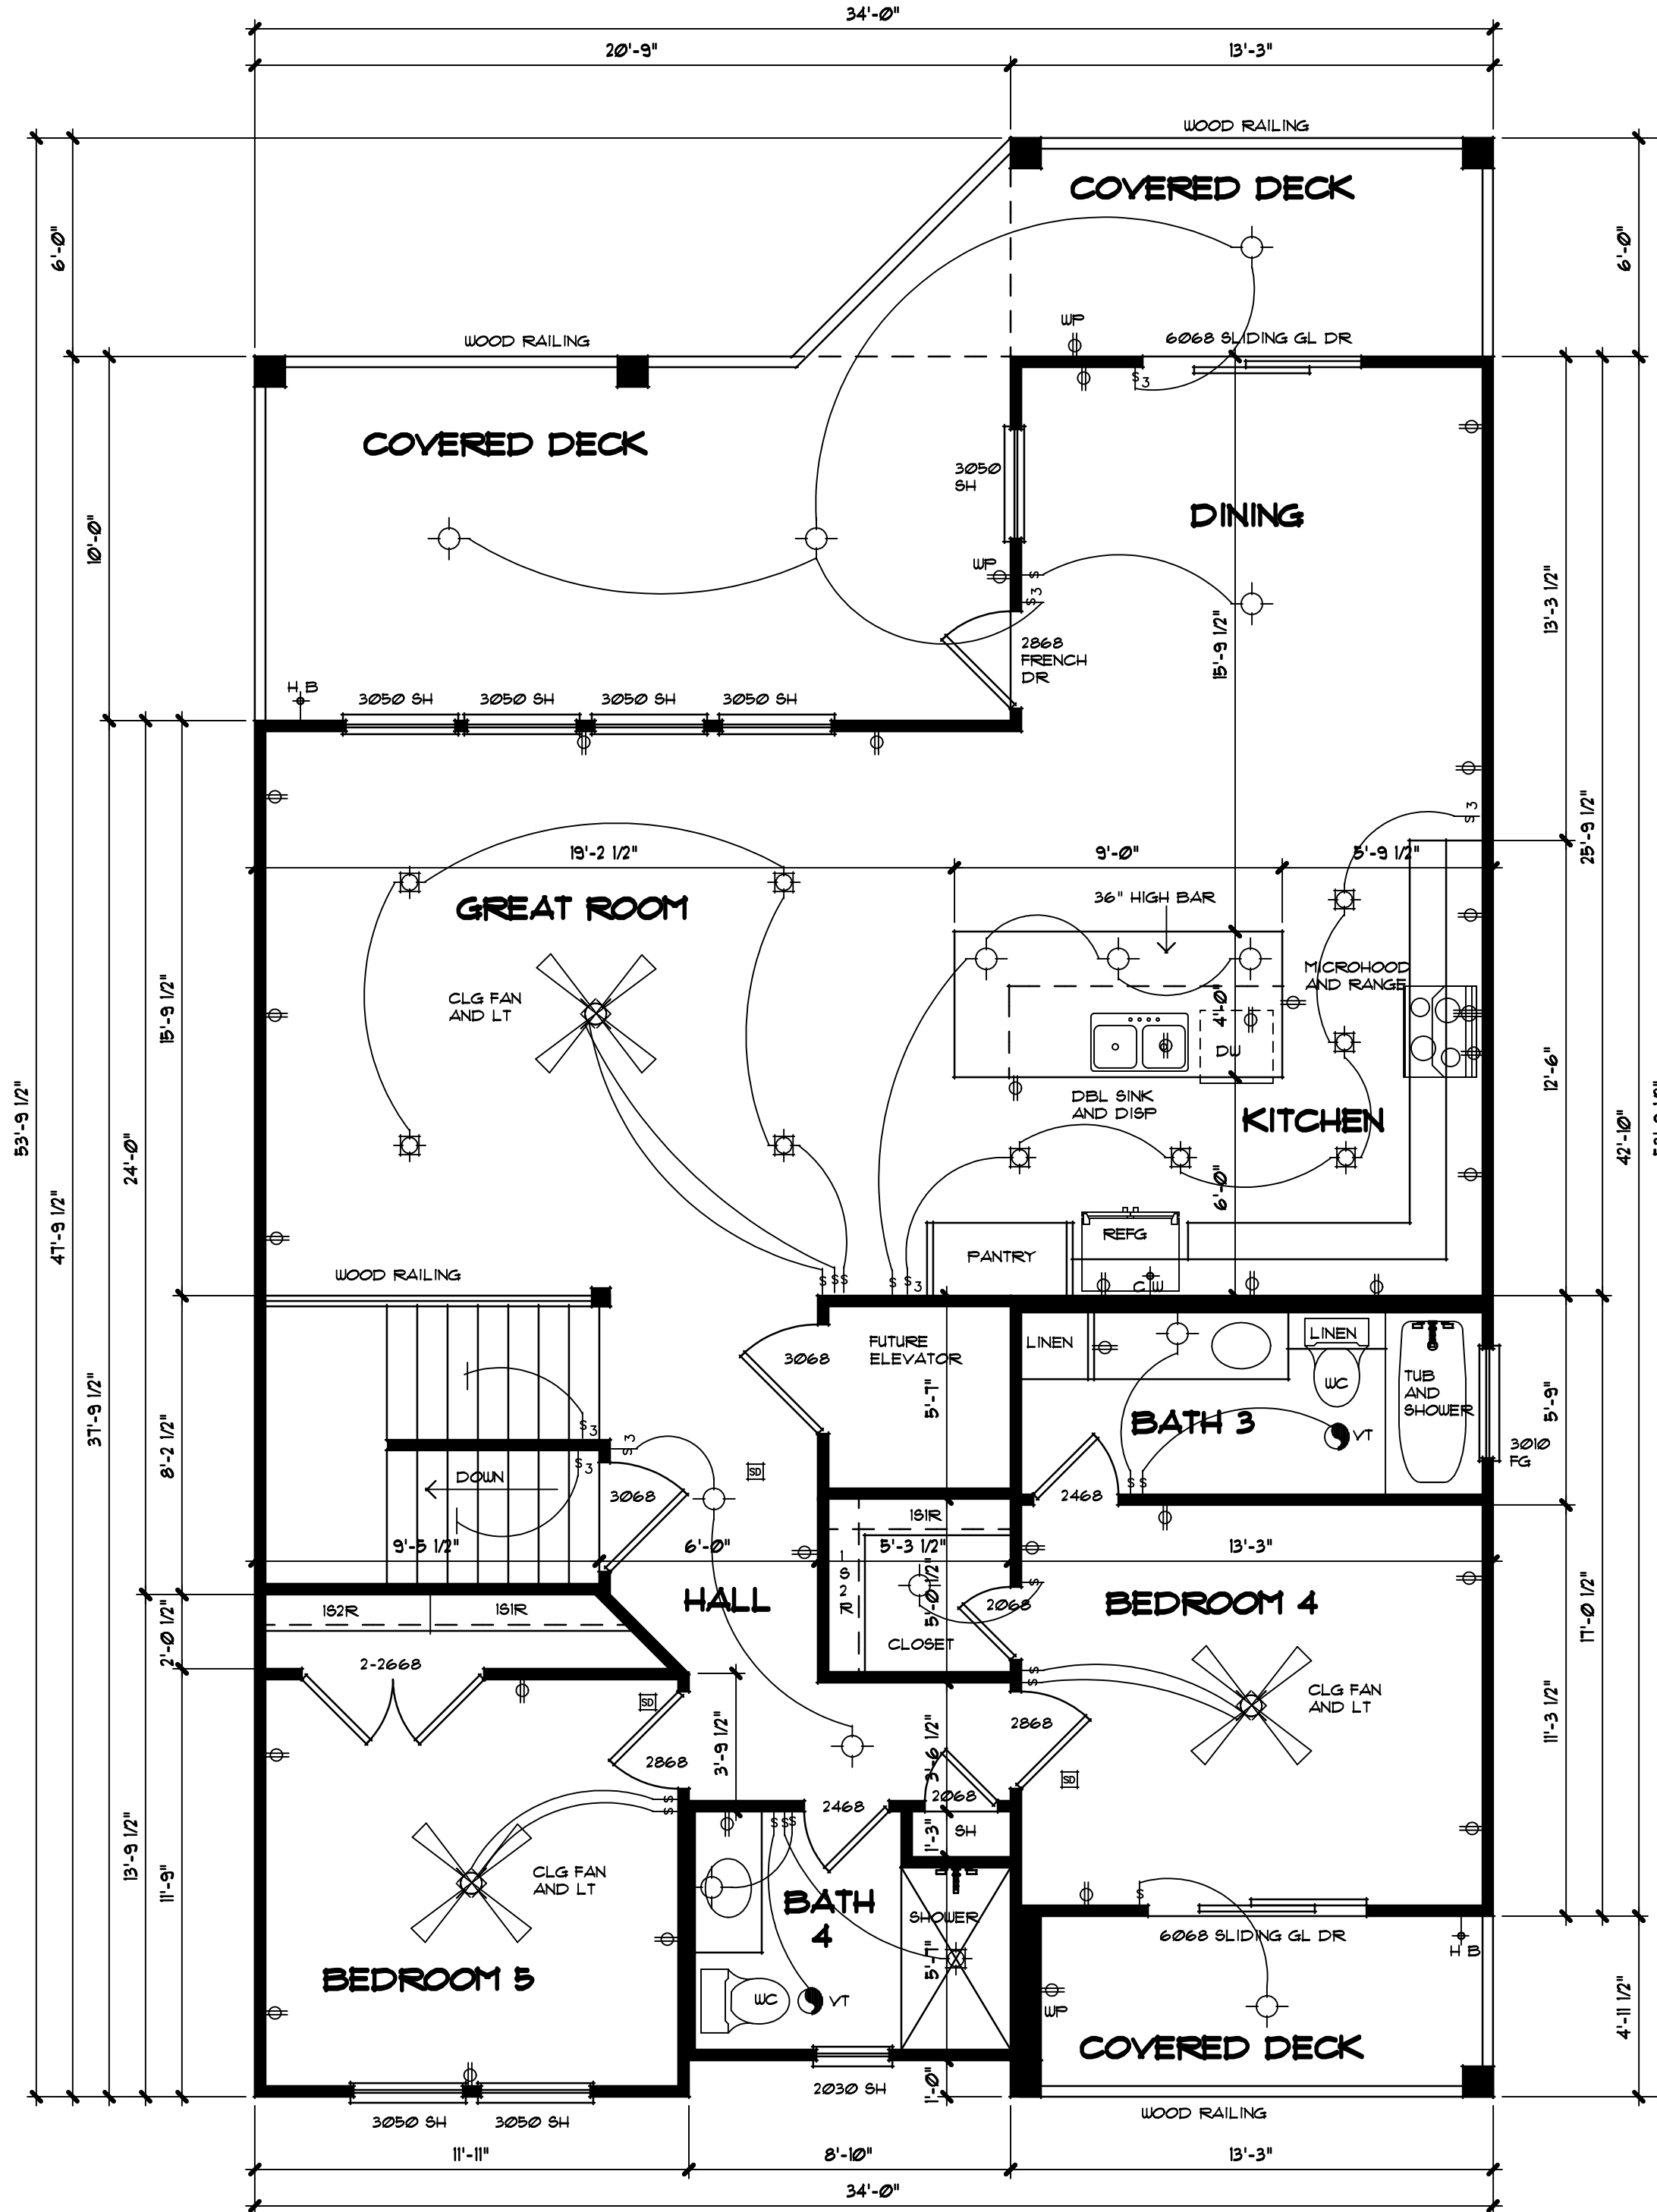

2ND FLOOR PLAN

SCALE 1/4"=1'-0"

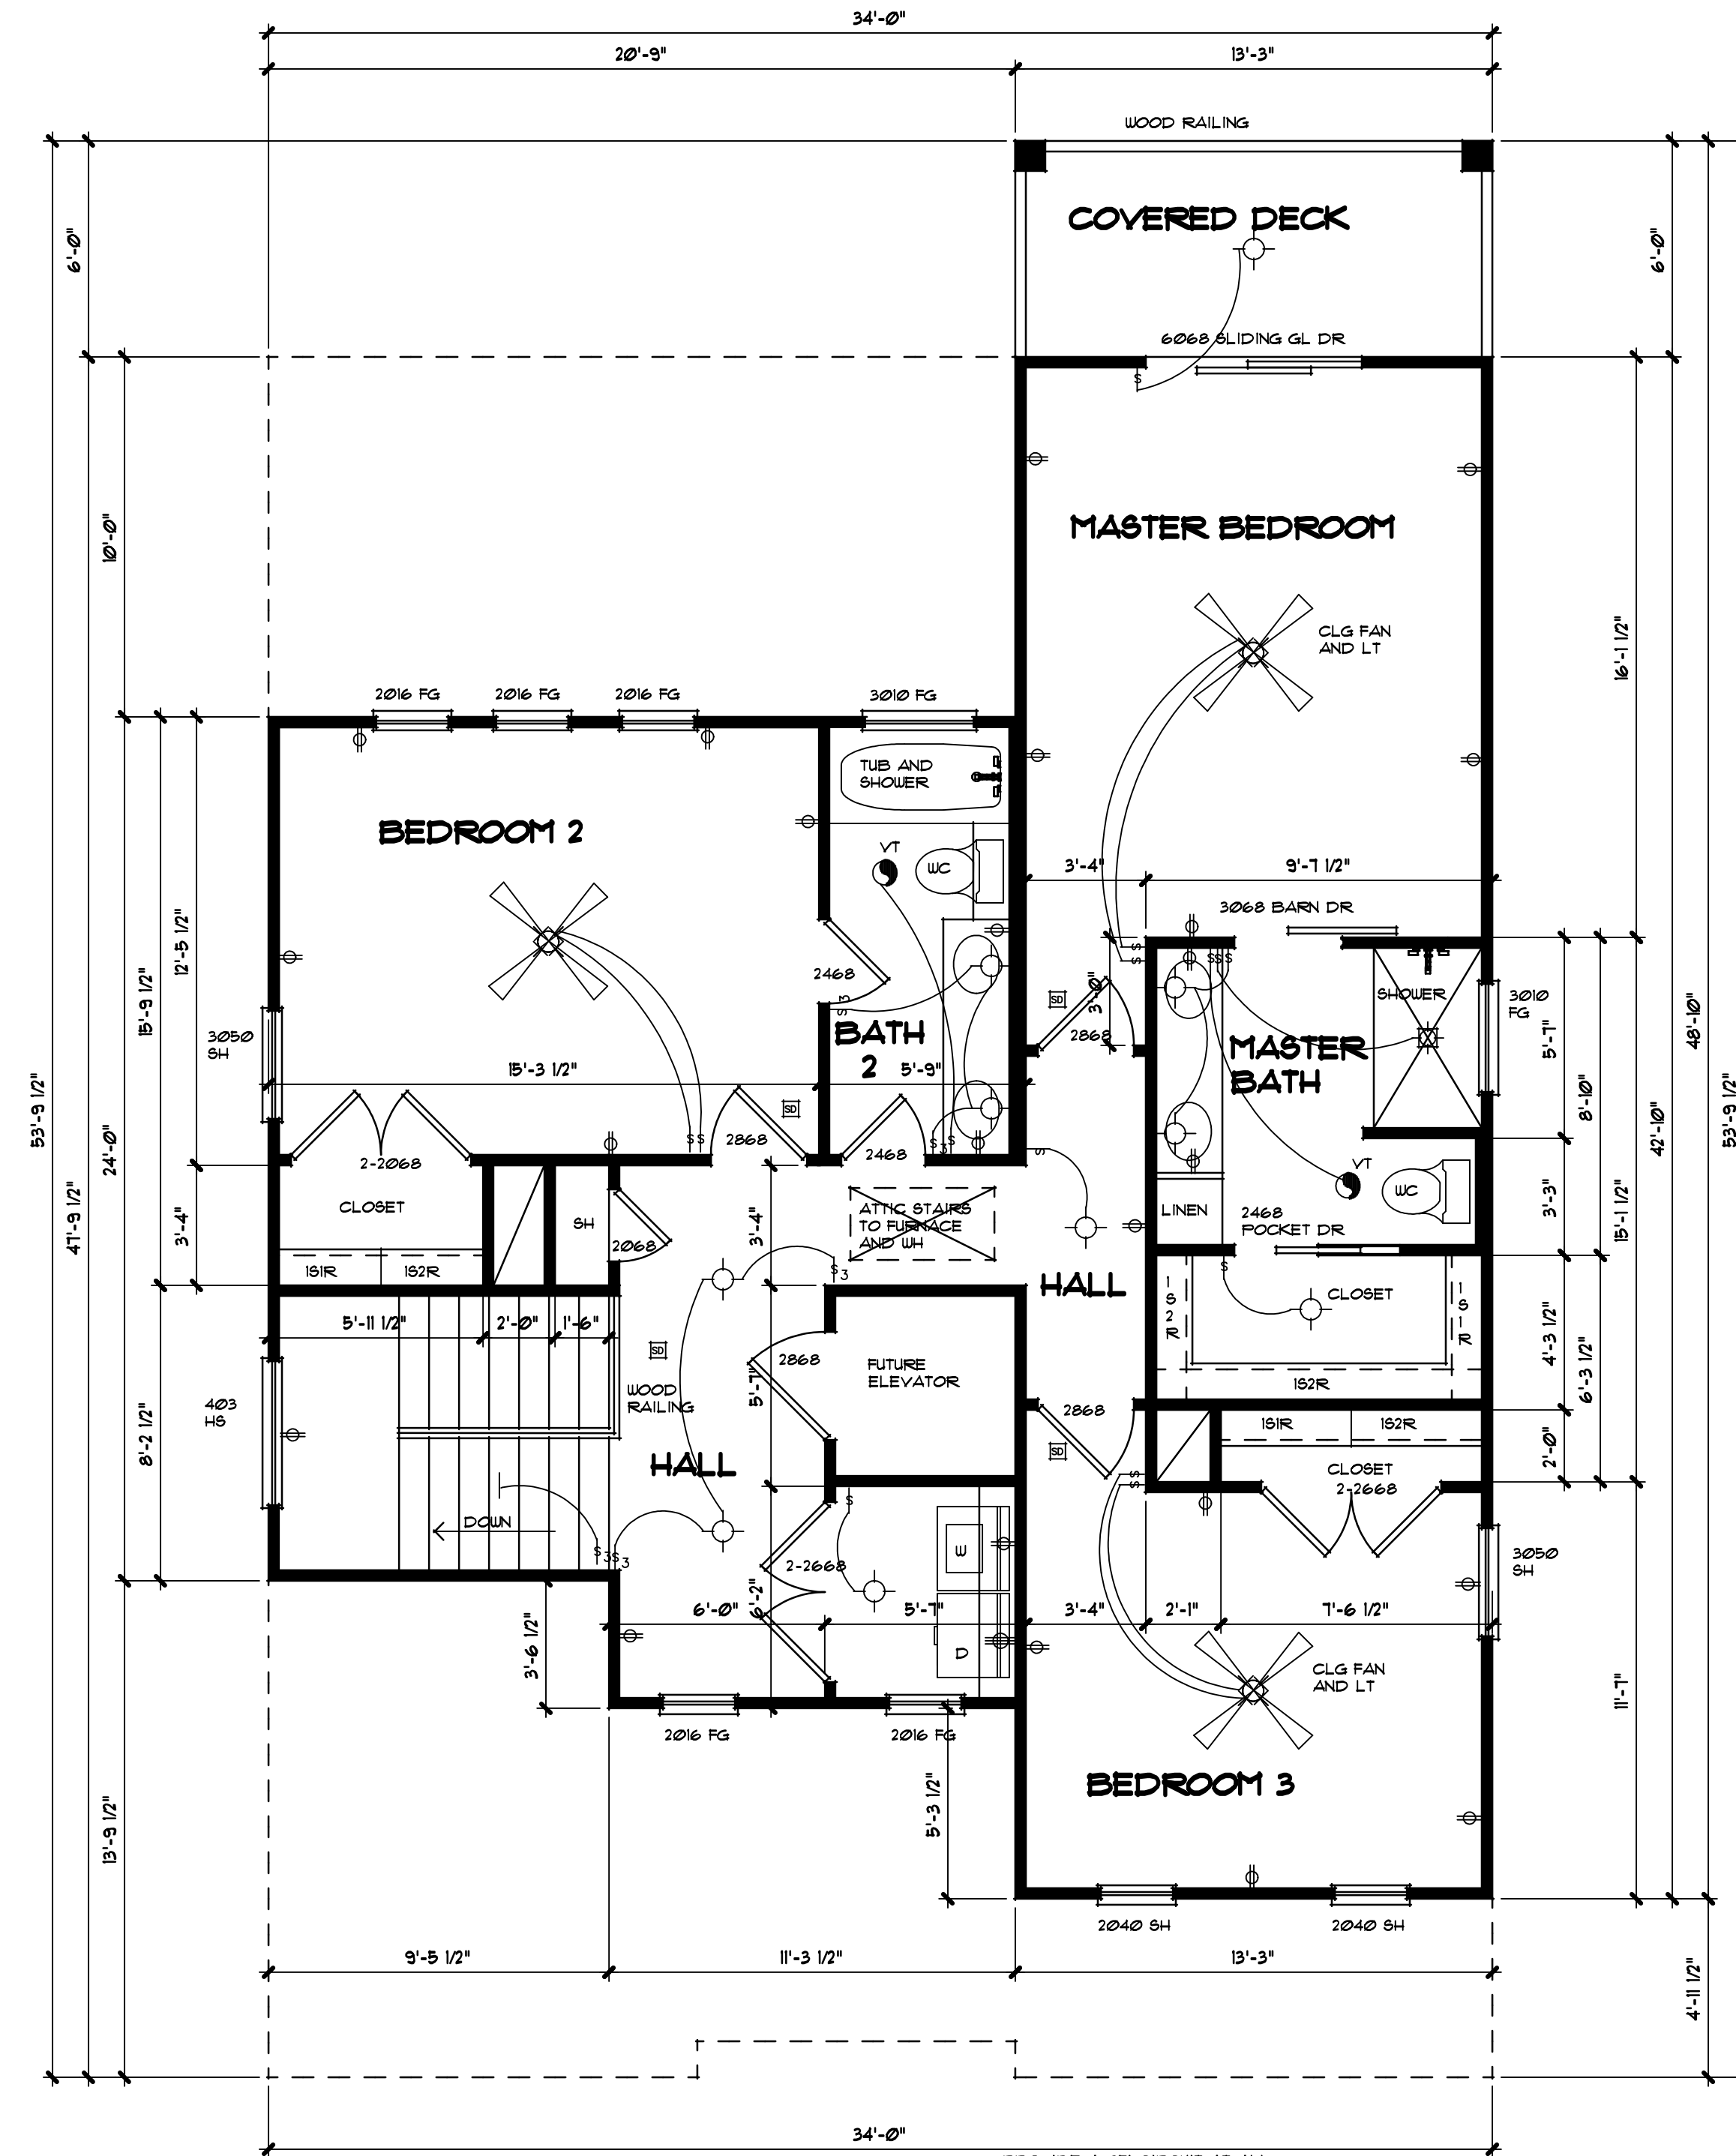


3RD FLOOR PLAN

SCALE 1/4"=1'-0"

PROVIDE A GFI CIRCUIT AT ALL BATH AND WP OUTLETS
PROVIDE INTERCONNECTED SMOKE ALARMS IN EACH SLEEPING ROOM, ALSO CARBON MONOXIDE DETECTORS OUTSIDE EACH SLEEPING ROOM, ON EACH STORY, IN THE HALL OR ADJACENT ROOM WHERE THE CEILING HEIGHT OF A ROOM OPEN TO THE HALL EXCEEDS THE HALL BY 2'-0". SMOKE ALARMS SHALL BE HARD WIRED WITH BATTERY BACKUP.

SMOKE DETECTORS OUTSIDE OF BEDROOMS TO BE CARBON MONOXIDE DETECTORS ALSO
ALL FG WINDOWS ARE TEMPERED GLASS
WINDOW HEADER HEIGHT IS 6'-8" AFF UNLESS NOTED

PROVIDE A SELF CLOSING DEVICE ON DOOR BETWEEN HOUSE AND GARAGE

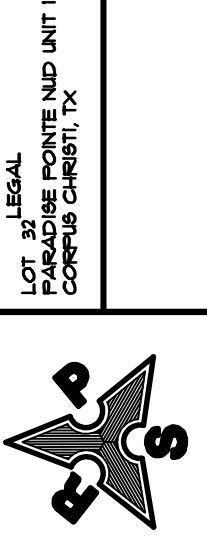

PARADISE POINTE AND COMPANY, INC.
10000 W. LEGAL
DALLAS, TEXAS 75243