


2ND FLOOR PLAN
SCALE 1/4"=1'-0"

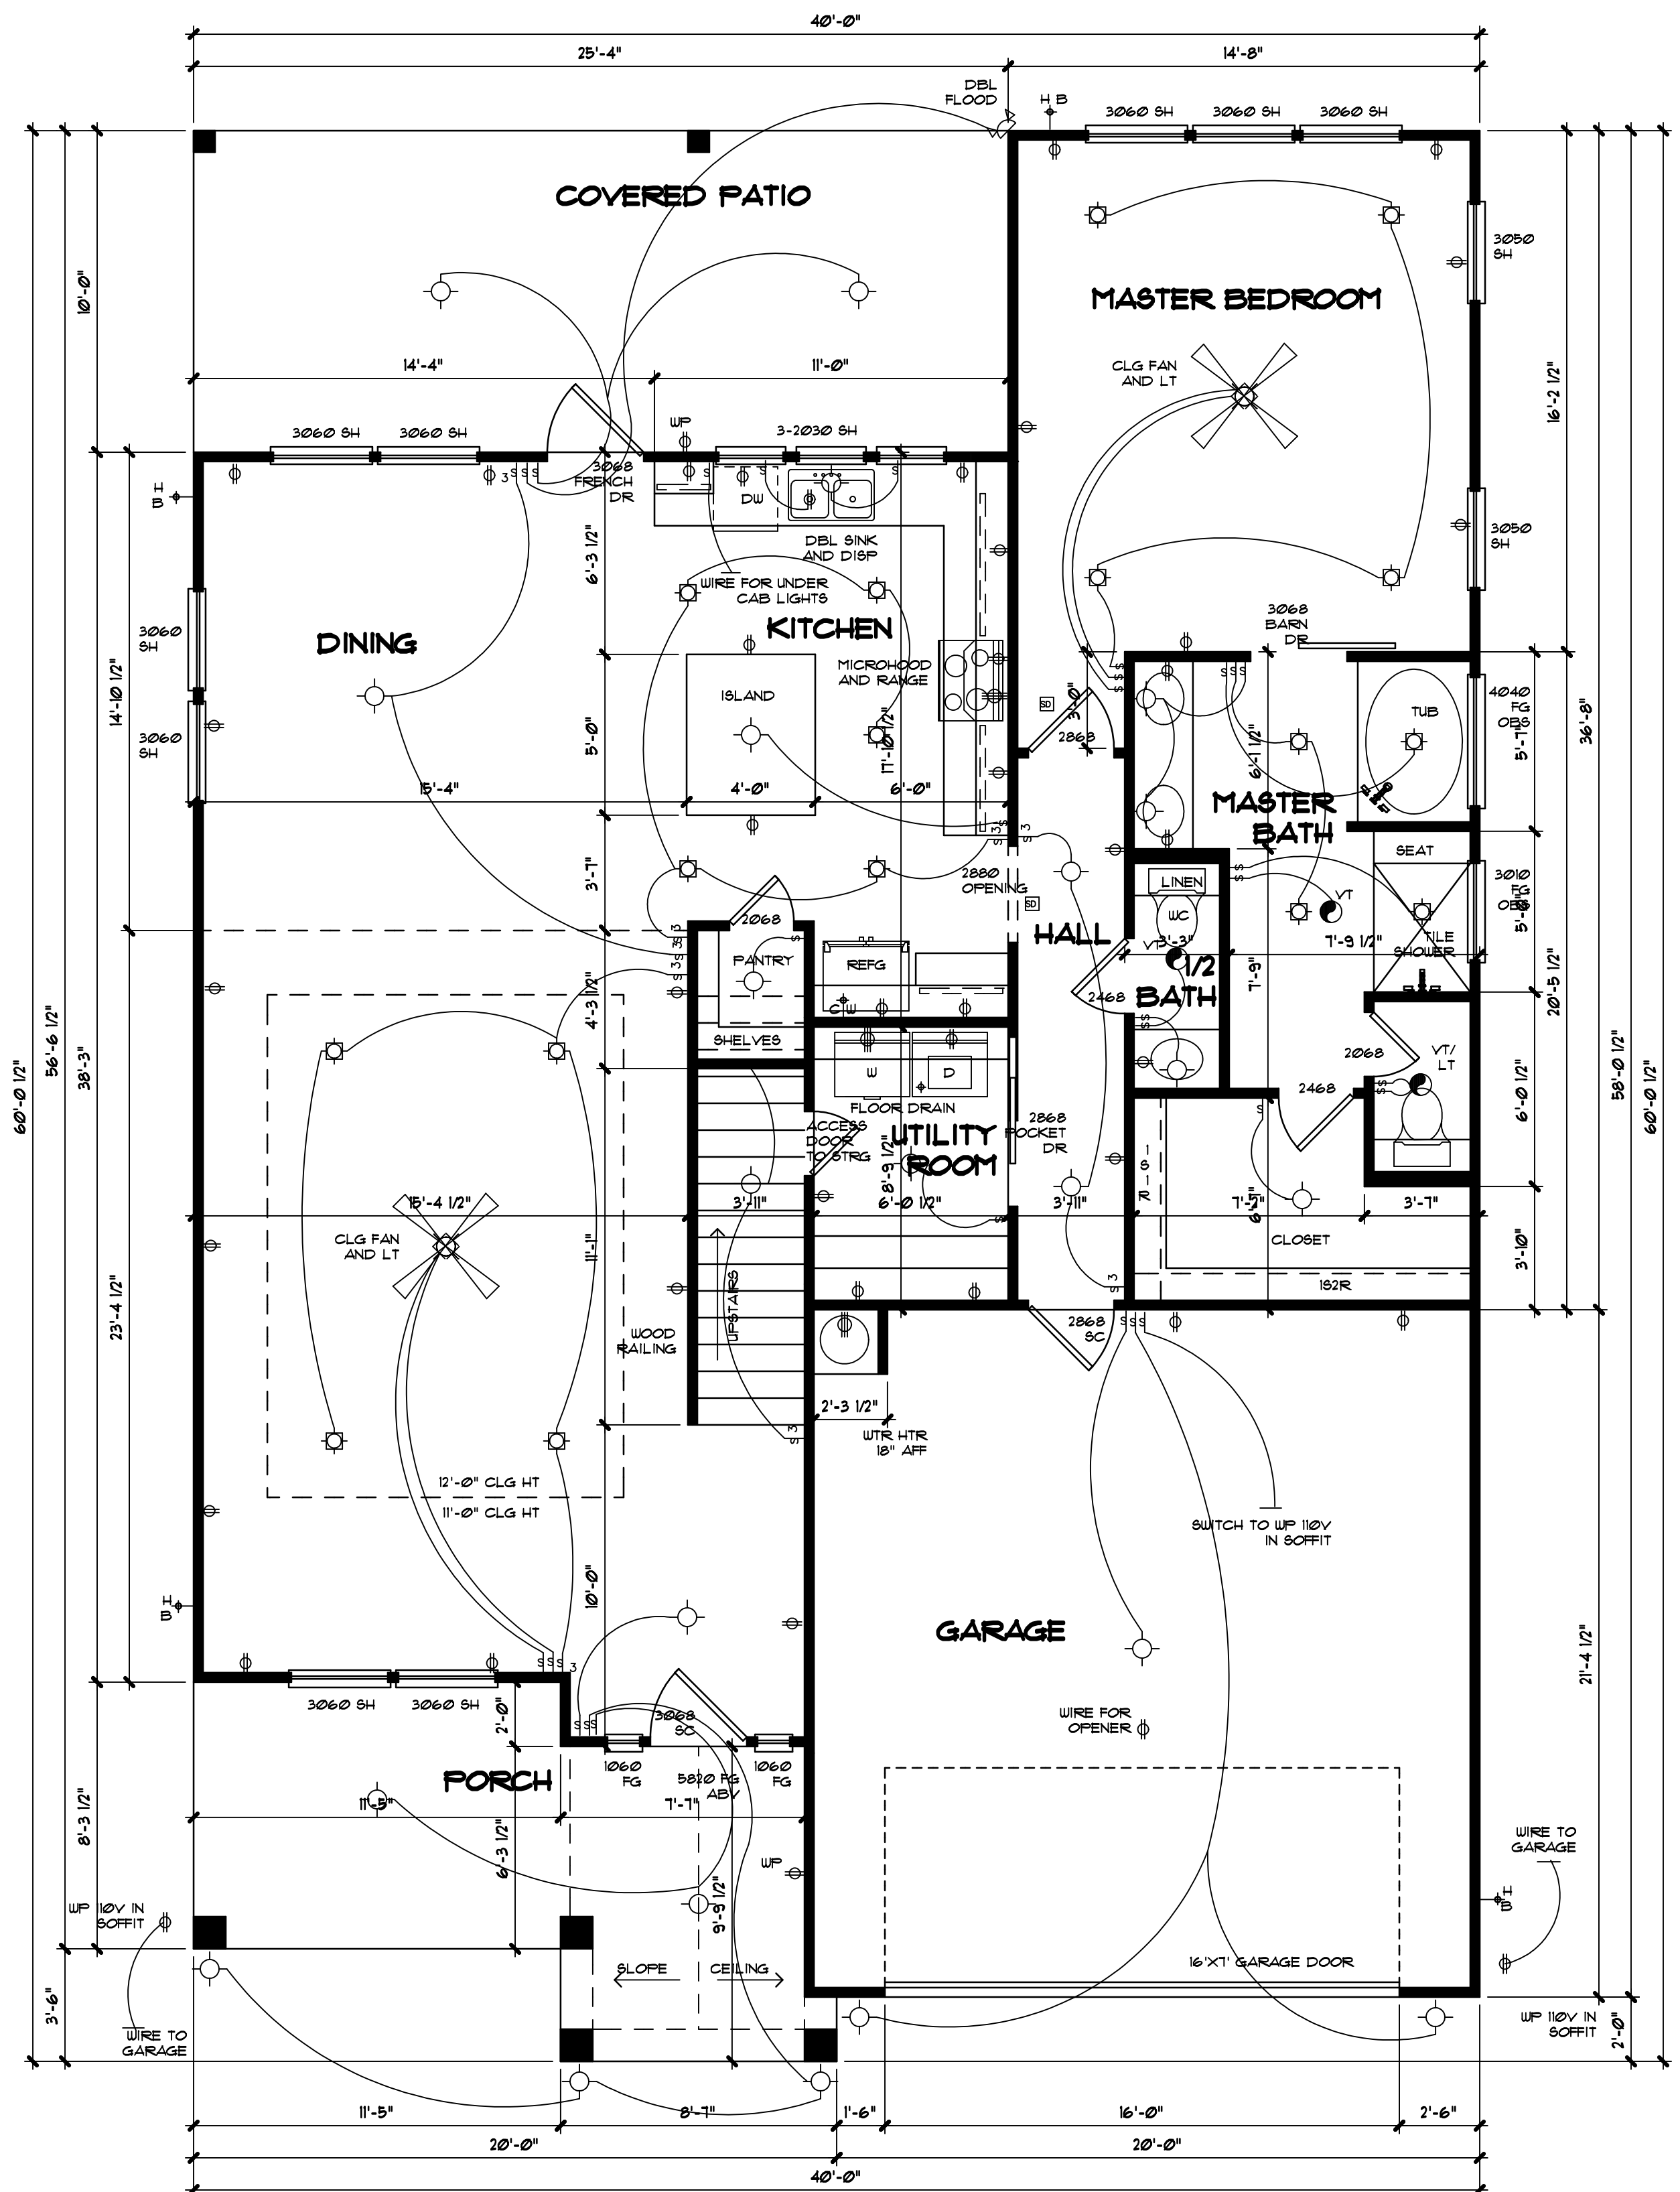

1ST FLOOR PLAN
SCALE 1/4"=1'-0"

PROVIDE A GFI CIRCUIT AT ALL BATH AND UP OUTLETS
PROVIDE INTERCONNECTED SMOKE ALARMS IN EACH SLEEPING ROOM, ALSO CARBON MONOXIDE DETECTORS OUTSIDE EACH SLEEPING ROOM, ON EACH STORY, IN THE HALL OR ADJACENT ROOM WHERE THE CEILING HEIGHT OF A ROOM OPEN TO THE HALL EXCEEDS THE HALL BY 24". SMOKE ALARMS SHALL BE HARD WIRED WITH BATTERY BACKUP.

SMOKE DETECTORS OUTSIDE OF BEDROOMS TO BE CARBON MONOXIDE DETECTORS ALSO
ALL FG WINDOWS ARE TEMPERED GLASS
WINDOW HEADER HEIGHT IS 6'-8" AFF UNLESS NOTED
PROVIDE A SELF CLOSING DEVICE ON DOOR BETWEEN HOUSE AND GARAGE